
 




SECOND FLOOR

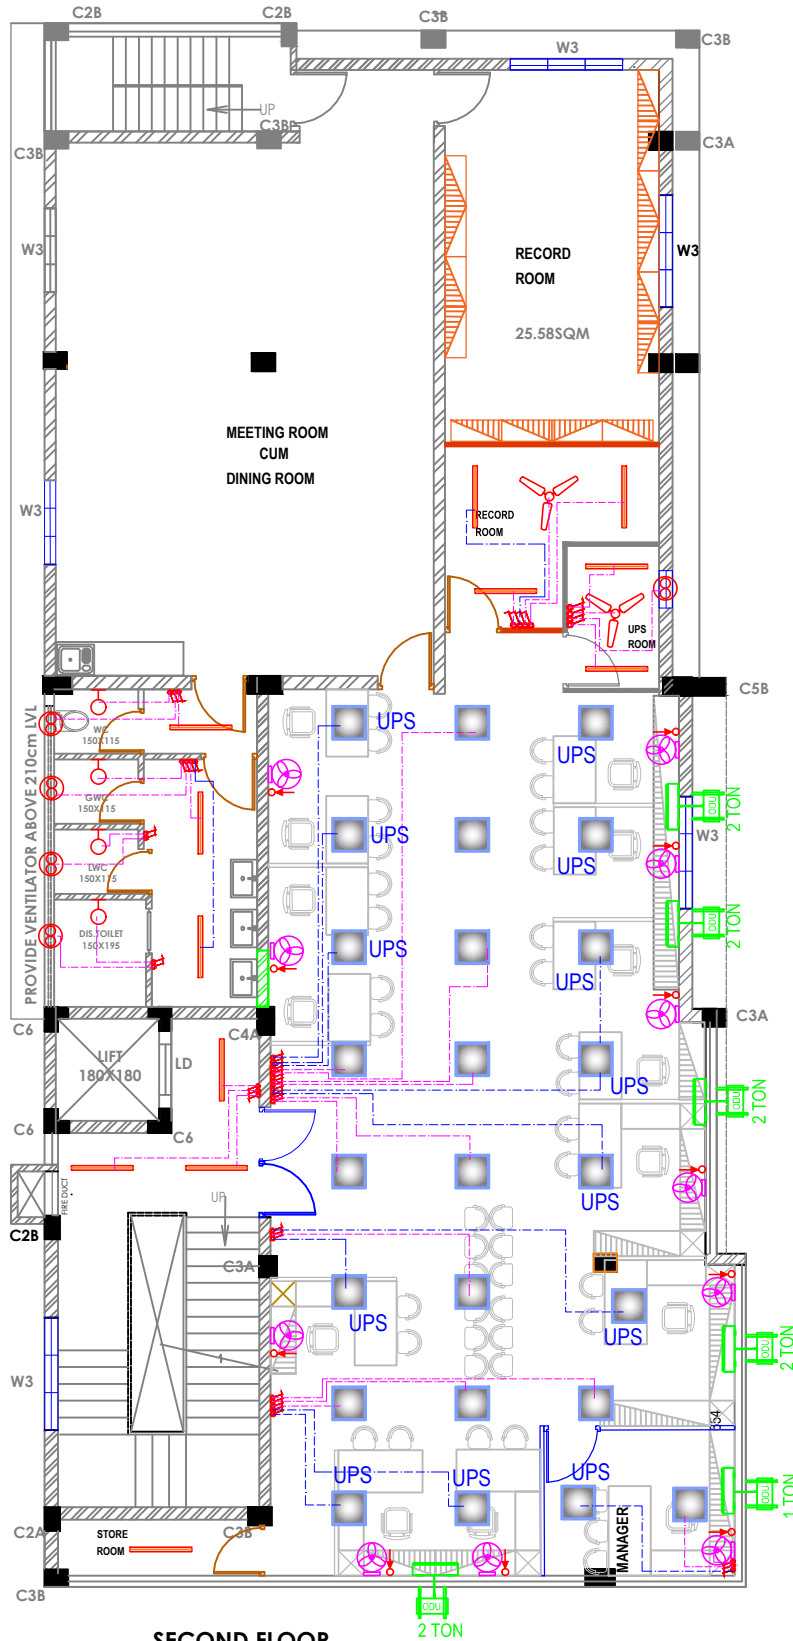

LEGEND	
	LED 2x2 Surface mounting light
	Wall fan
	Bracket light
	Ceiling fan
	Bell Point.
	6A plug point combined
	Led Tube Light
	Exhaust fan
	AC Indoor
	6A socket for wall fan
	6A switch board



ENARC CONSULTANTS
ARCHITECTS AND ENGINEERS
M. G. Road, Thrissur - 1.
Tel. : +91 (487) 2441901
E-mail : office@enarc.net.in

**PROPOSED INTERIOR FURNISHING
FOR UNITED INDIA INSURANCE
COMPANY OD HUB**


ELECTRICAL LIGHTING LAYOUT

LEGEND
CUPBOARD 75 CM HEIGHT
SLOTTED ANGLE RACK FULL HEIGHT
FULL GLAZED PARTITIONS
SOLID PARTITIONS
CASH COUNTER PARTITIONS (180 cm ht Half glazed)
SEMI PARTITIONS
FIRE RATED CEMENT PARTITIONS

Drawn By	RAGHI K R
Architect	Ar.Praveen.P B. Arch [Reg], A.I.I.A, A.I.I.D

Chief Architect	Ar. K. RAMAKRISHNAN B.Sc.(Engg), F.I.E, C. Eng (I), F.I.V, F.I.I.A. (Regd), A.I.I.D
-----------------	---

Date : 12-11-2025
Drawing No: 01
Scale : N T S
All Dimensions are in CMs.

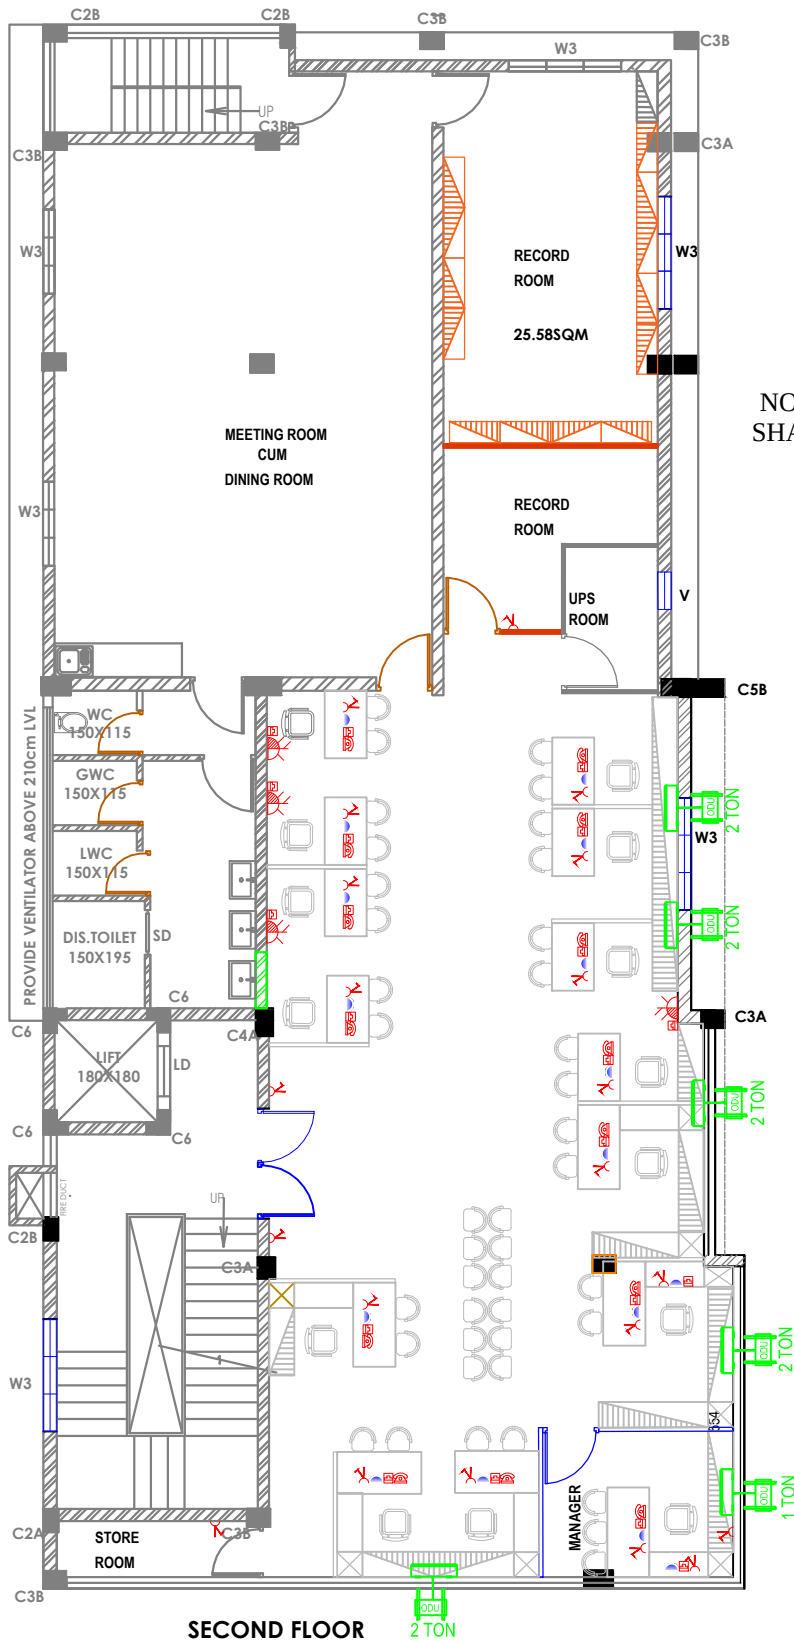

NOTE- NETWORK RACK POWER PLUG SHALL FIXED AT SUITABLE LOCATION

LEGEND	
	Telephone
	UPS Plug Point - 3 outputs.
	6/16 A Power Point.
	6 A Power Point.
	TV POINT
	DATA POINT

SECOND FLOOR



ENARC CONSULTANTS
ARCHITECTS AND ENGINEERS
M. G. Road, Thrissur - 1.
Tel. : +91 (487) 2441901
E-mail : office@enarc.net.in

PROPOSED INTERIOR FURNISHING
FOR UNITED INDIA INSURANCE
COMPANY OD HUB


ELECTRICAL POWER LAYOUT

LEGEND	
	CUPBOARD 75 CM HEIGHT
	SLOTTED ANGLE RACK FULL HEIGHT
	FULL GLAZED PARTITIONS
	SOLID PARTITIONS
	CASH COUNTER PARTITIONS (180 cm ht. Half glazed)
	SEMI PARTITIONS (120 cm ht. Half glazed)
	FIRE RATED CEMENT PARTITIONS

Drawn By	RAGHI K R
Architect	Ar.Praveen.P B. Arch [Reg], A.I.A, A.I.I.D

Chief Architect	Ar. K. RAMAKRISHNAN B.Sc.(Engg), F.I.E, C. Eng (I), F.I.V, F.I.I.A. (Regd), A.I.I.D
-----------------	---

Date : 12-11-2025
Drawing No: 02
Scale : N T S
All Dimensions are in CMs.

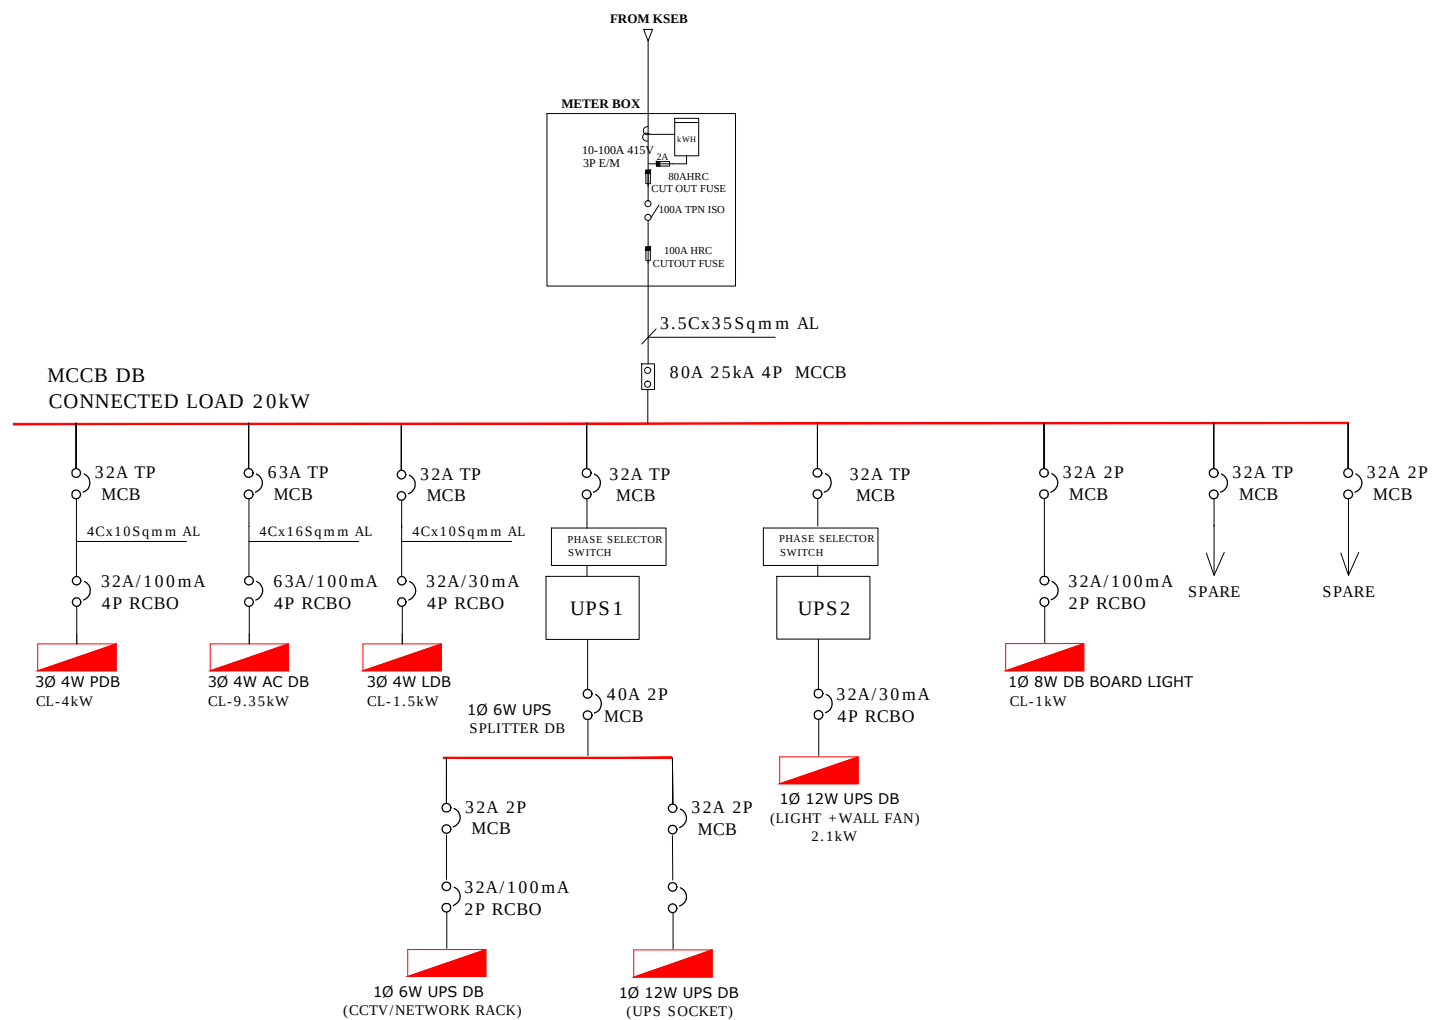

ENARC CONSULTANTS
ARCHITECTS AND ENGINEERS

M. G. Road, Thrissur - 1.
Tel. : +91 (487) 2441901
E-mail : office@enarc.net.in

UNITED INDIA INSURANCE
OD HUB THRISSUR

METER BOARD TO MCCB DB